



HANDICAP RAMP RAILINGS
SCALE: 1" = 1'-0"

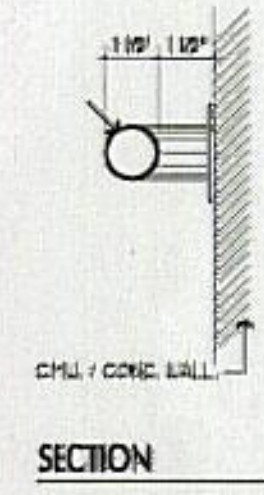


SECTION

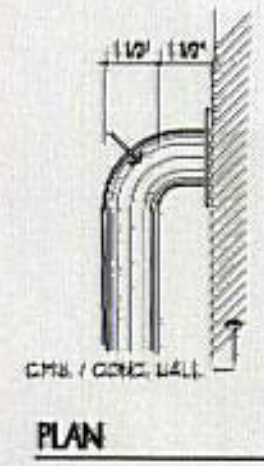


PLAN


HANDRAIL DETAIL
SCALE: 1" = 1'-0"

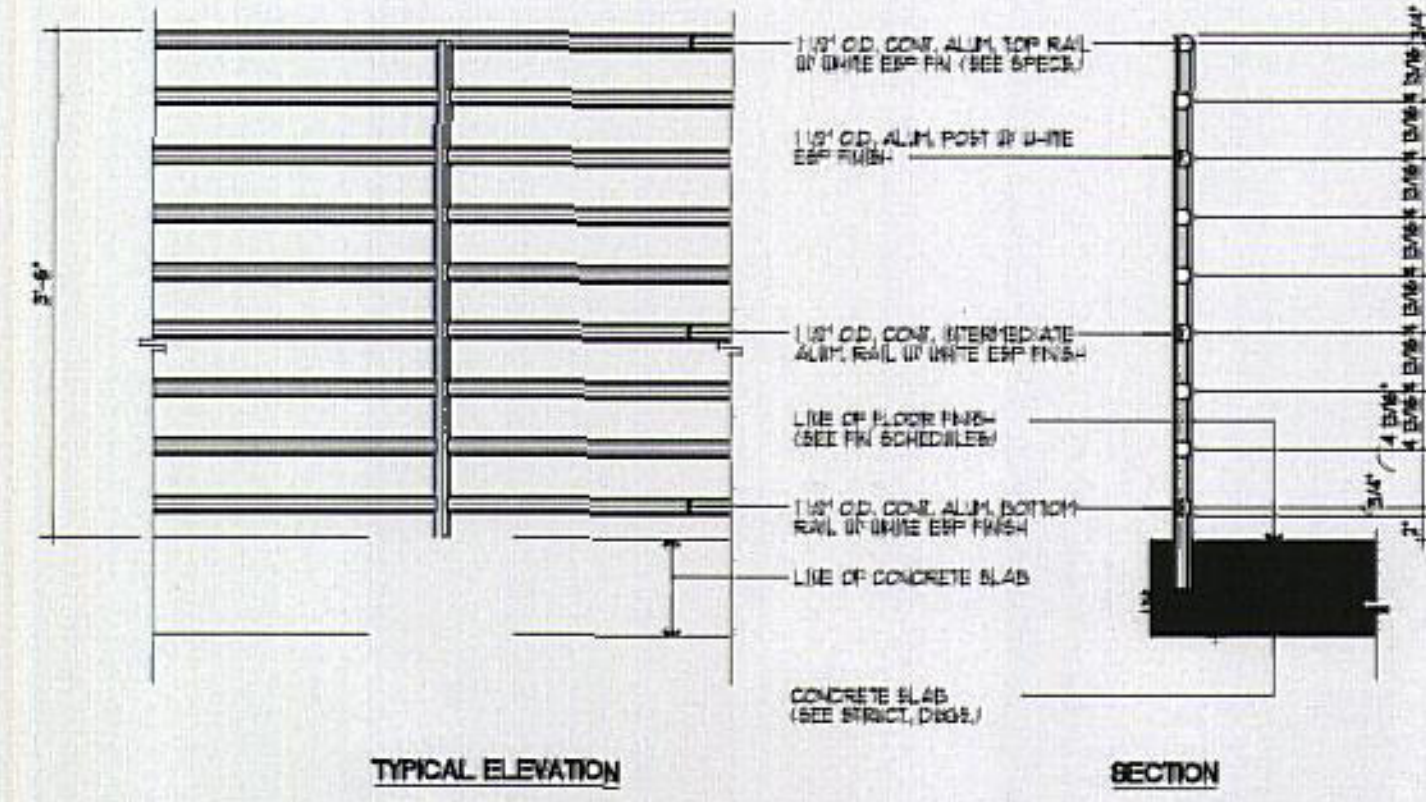

STAIR AND TYP. UPPERMOST LANDING DETAIL
SCALE: 1" = 1'-0"

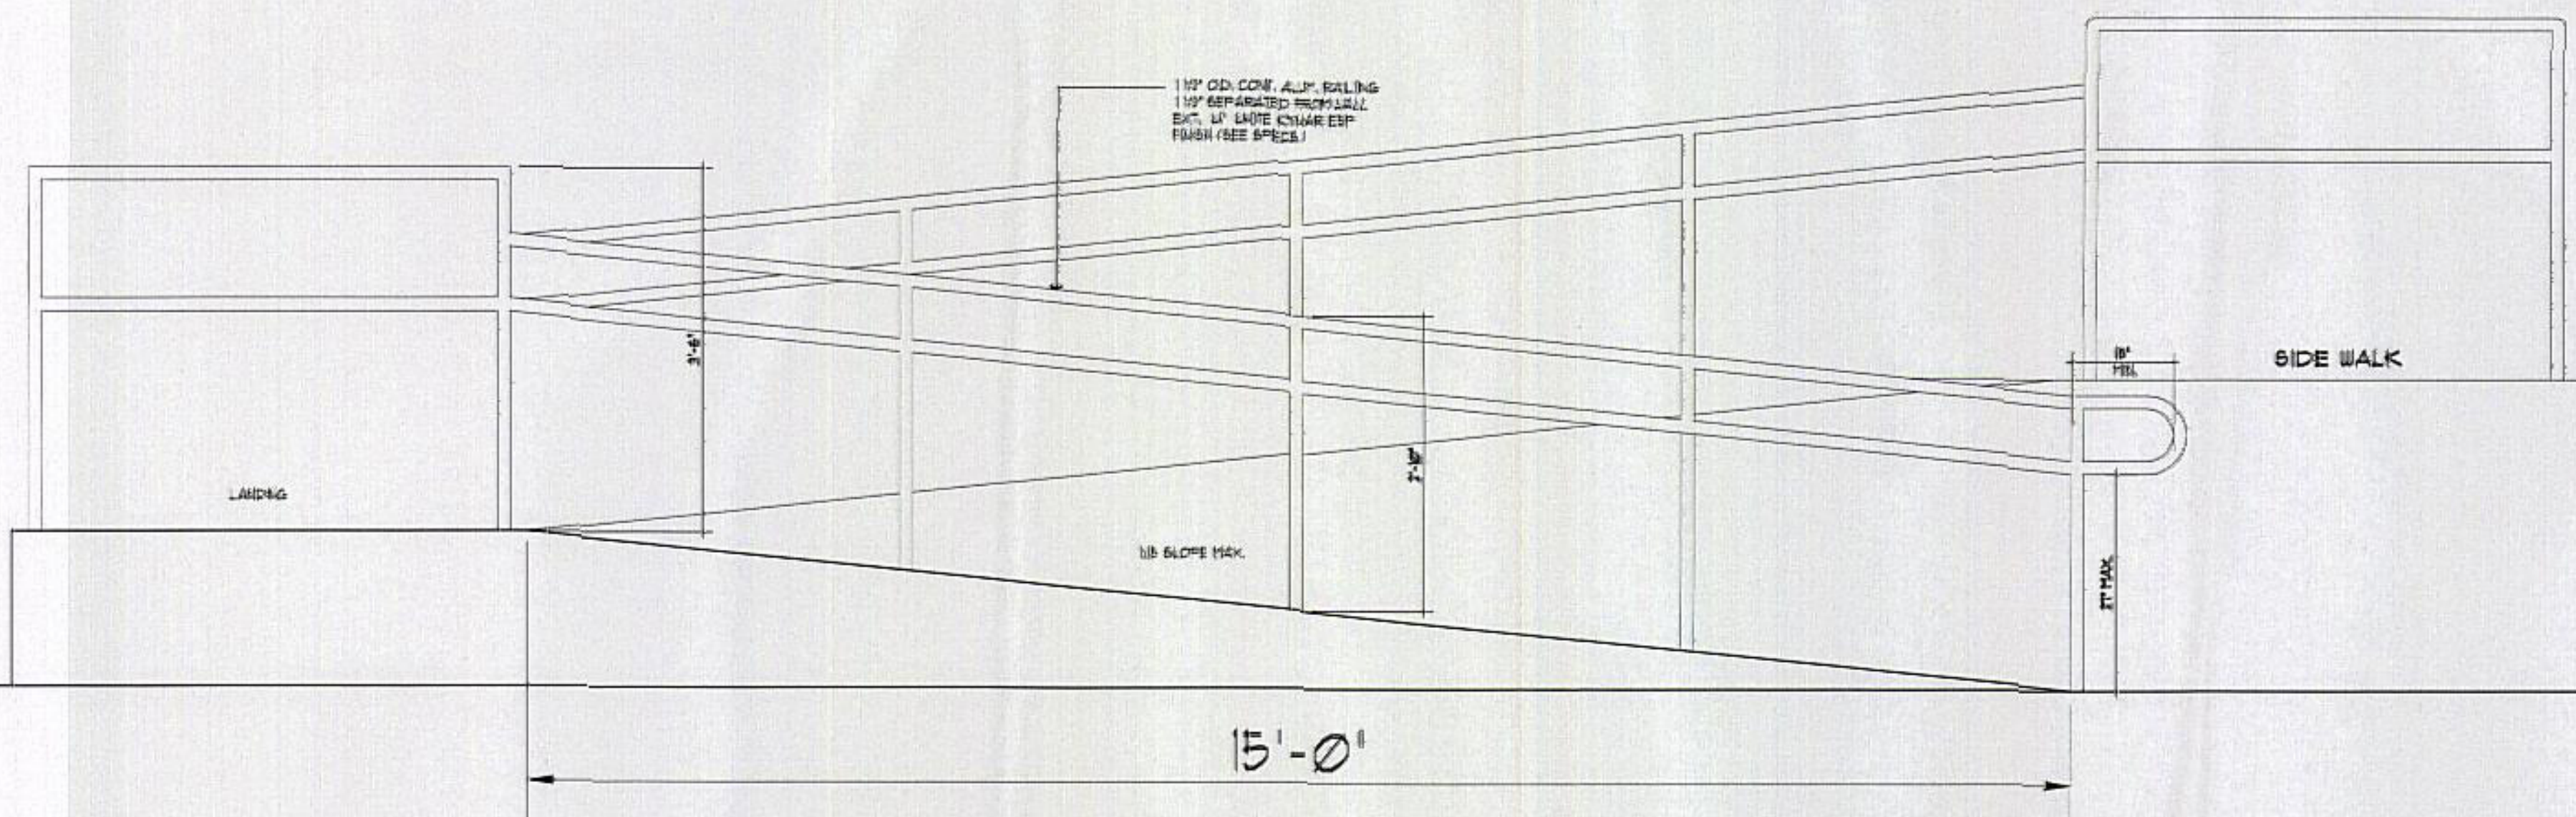

HANDICAP RAMP RAILINGS
SCALE: 3/8" = 1'-0"

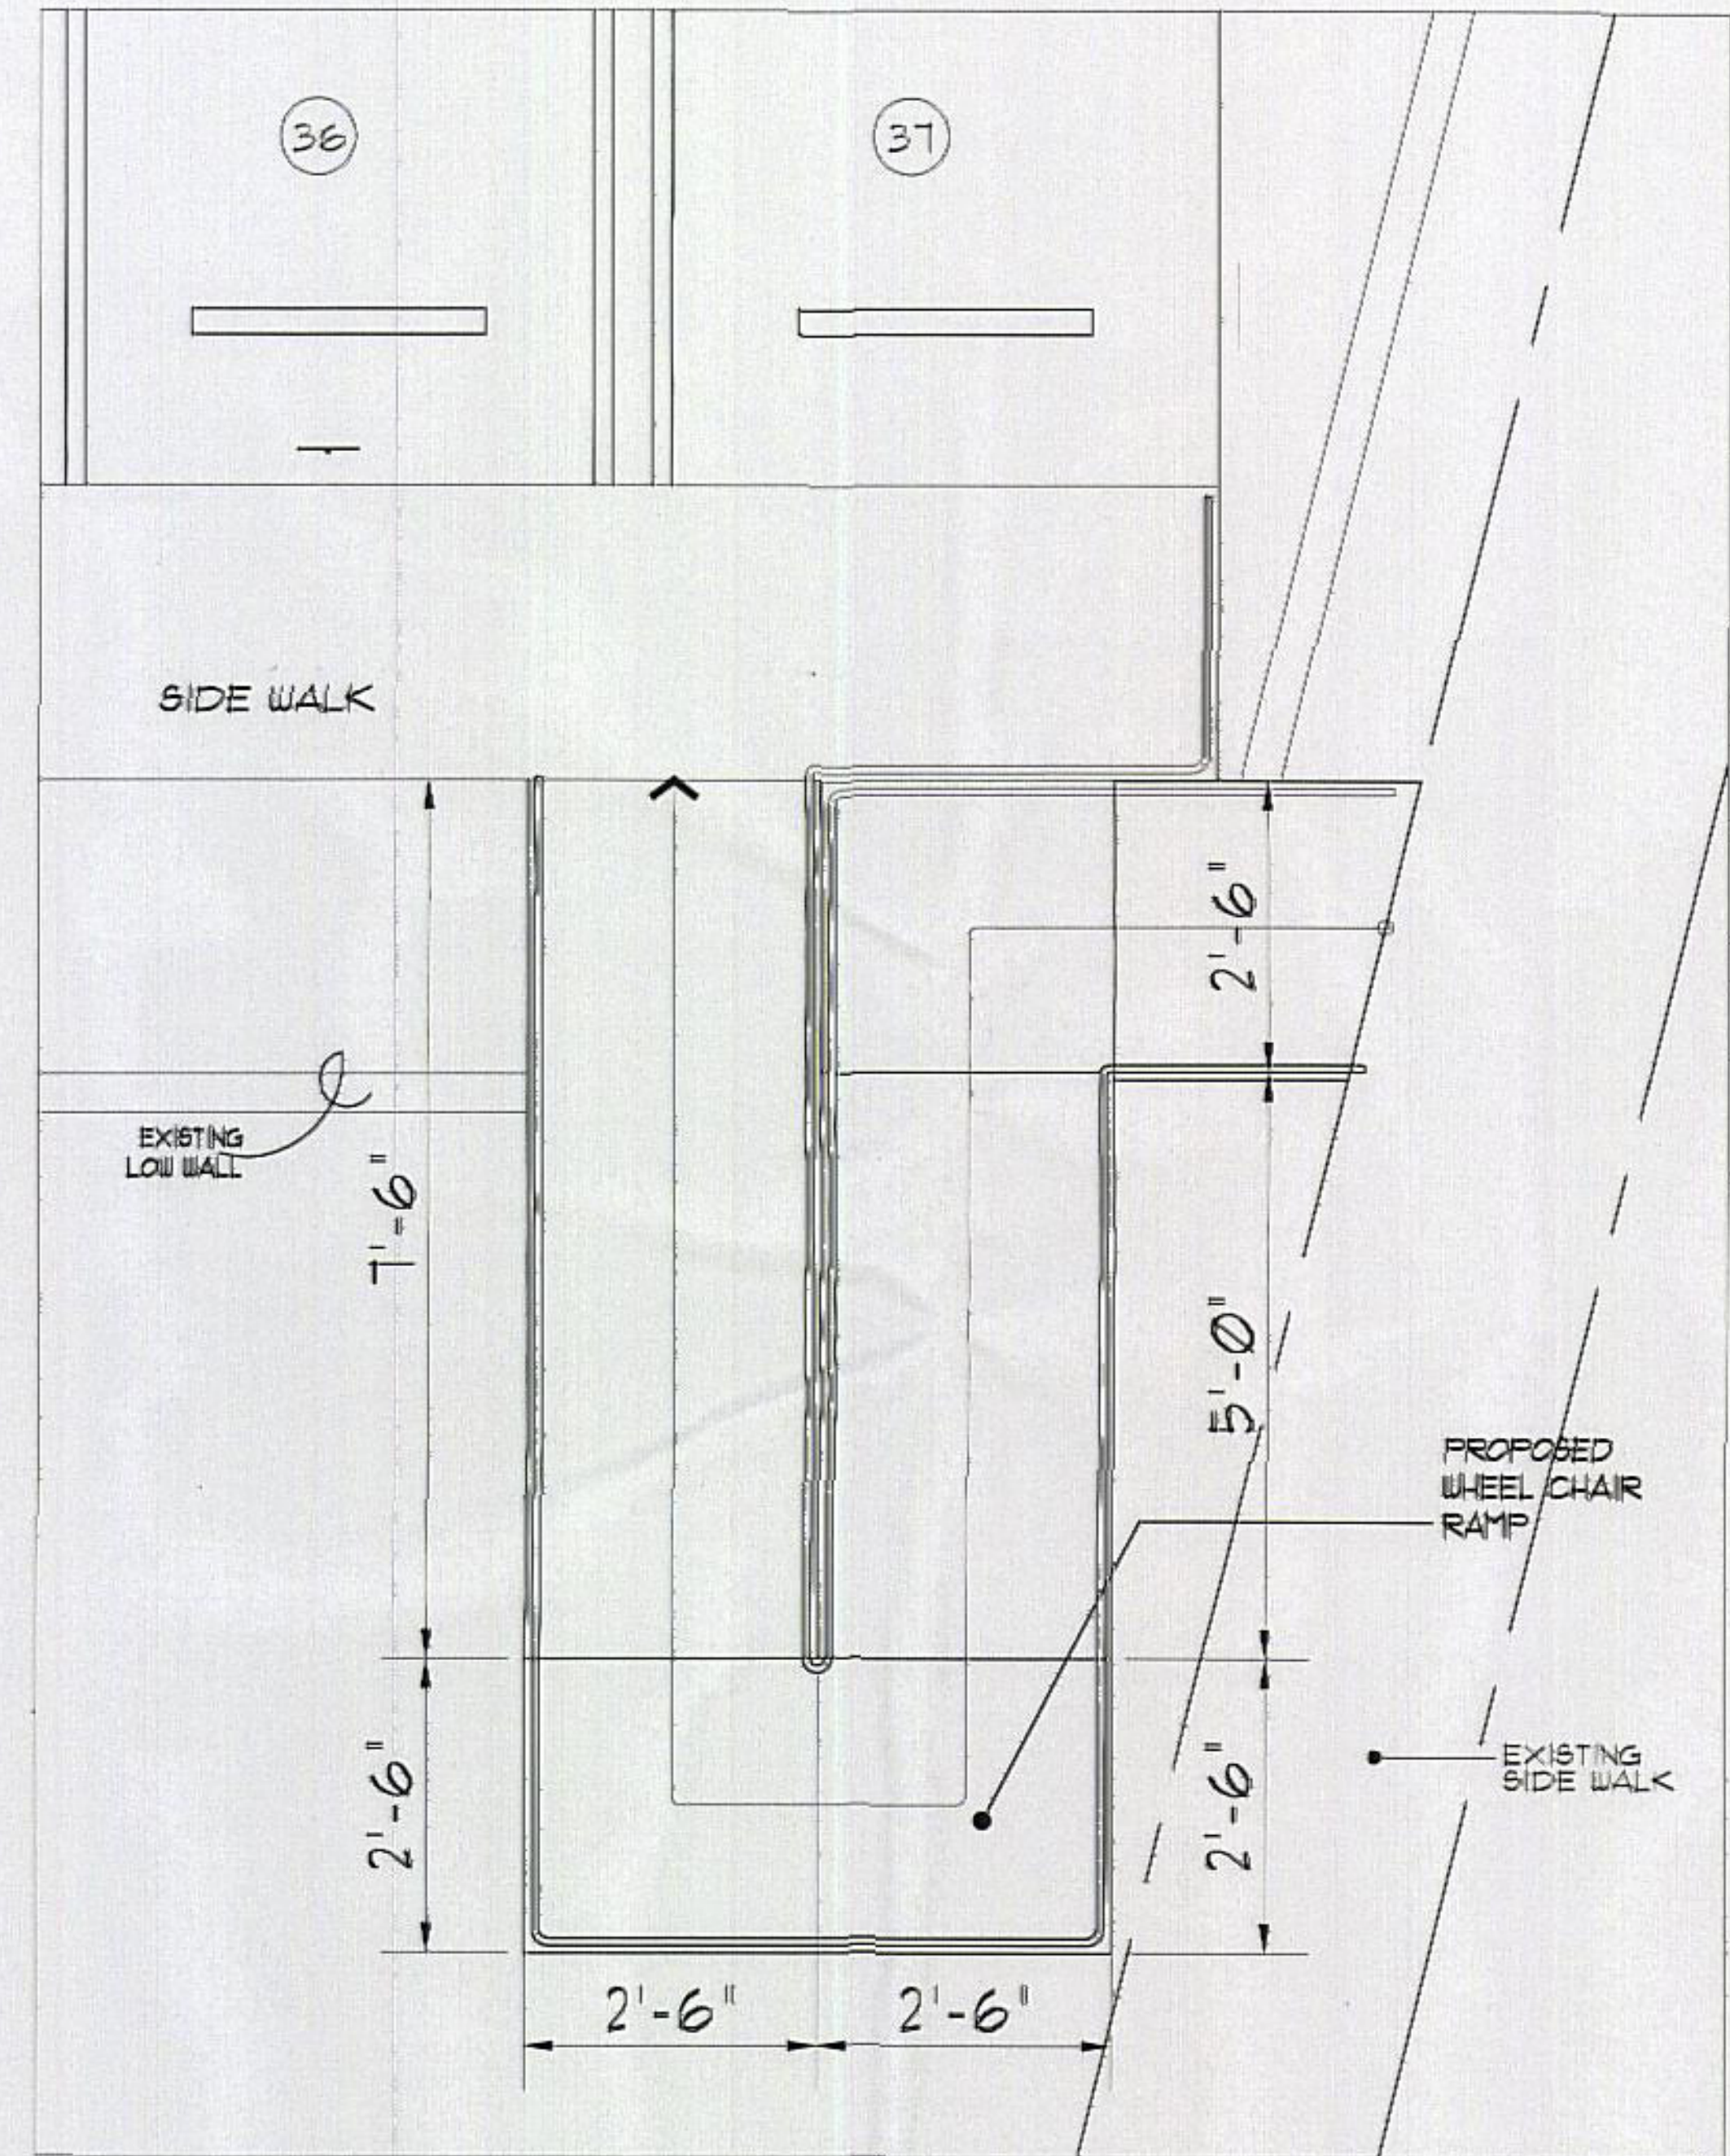

HANDICAP RAMP FLOOR PLAN
SCALE: 1" = 1'-0"

Oscar Familia & Asociados
Design Consultant
4444 S.W. 75TH AVENUE
SUITE 101-A MIAMI, FLORIDA 33154
PHONE: (305) 645-3134
FAX: (305) 645-3187
EMAIL: Ofamilia@BellSouth.com

J.R.F. ARCHITECT
JOSE R. FIGUEROA
REG. # 5808
8611 S.W. 143TH AVENUE
MIAMI, FLORIDA 33175
TELEPHONE: (305) 226-3459

MISTRI CONSTRUCTION, INC.
Wenceslao S. Martinez
General Contractor
CCC # 0504728
4630 W. University Dr.
Coral Springs, FL 33067
www.mistriconstruction.com
EMAIL: sales@mistriconstruction.com
P.H. 954-729-6898
FAX: 954-345-1566


INTERIOR AND EXTERIOR REMODELING EXISTING BUILDING FOR:
PEDIATRIC RESPIRATORY CENTER
DR. JORGE SALLENT
FEDERAL HWY NORTH PALM BEACH, FLORIDA
500
TELEPHONE: (954) 729-6898

Jose P. Figuera
SEA

REVISIONS:

1-	
2-	
3-	

DATE: DEC. 2008
SCALE: SHOWN
DRAWN: J.P.F., P.L., N.Z.
JOB NO. 12008-SALLENT

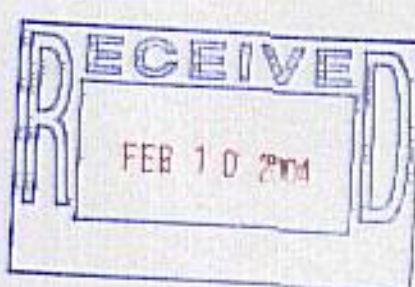

SP-4
SHEET NO. 1 OF